



OVERALL EXISTING SITE PLAN
SCALE: 1"=100'-0"

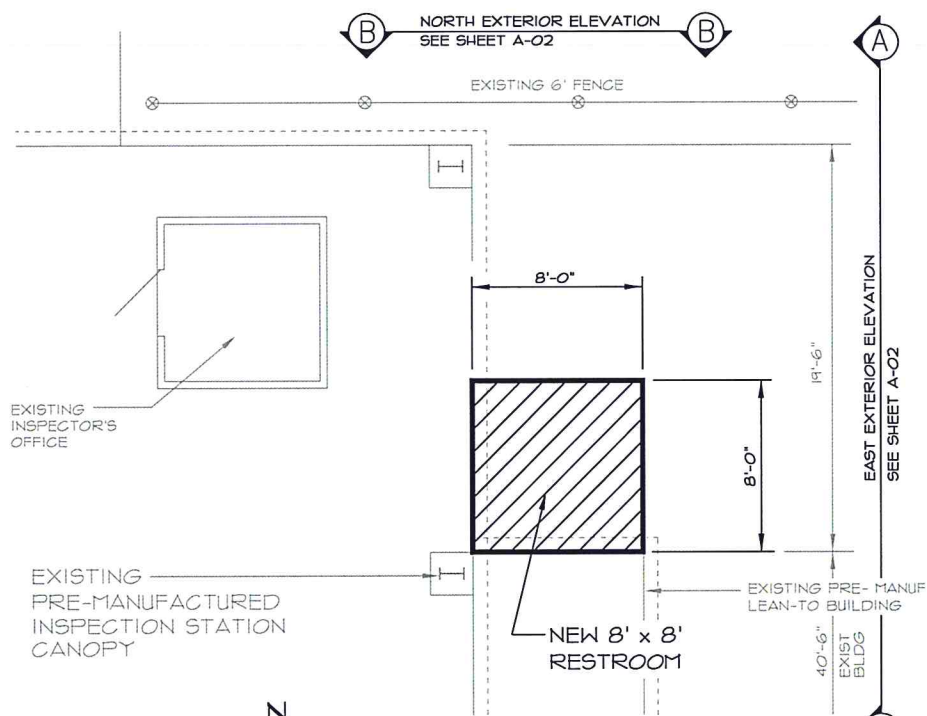

ENLARGED EXISTING FLOOR PLAN
SCALE: 1/4"=1'-0"

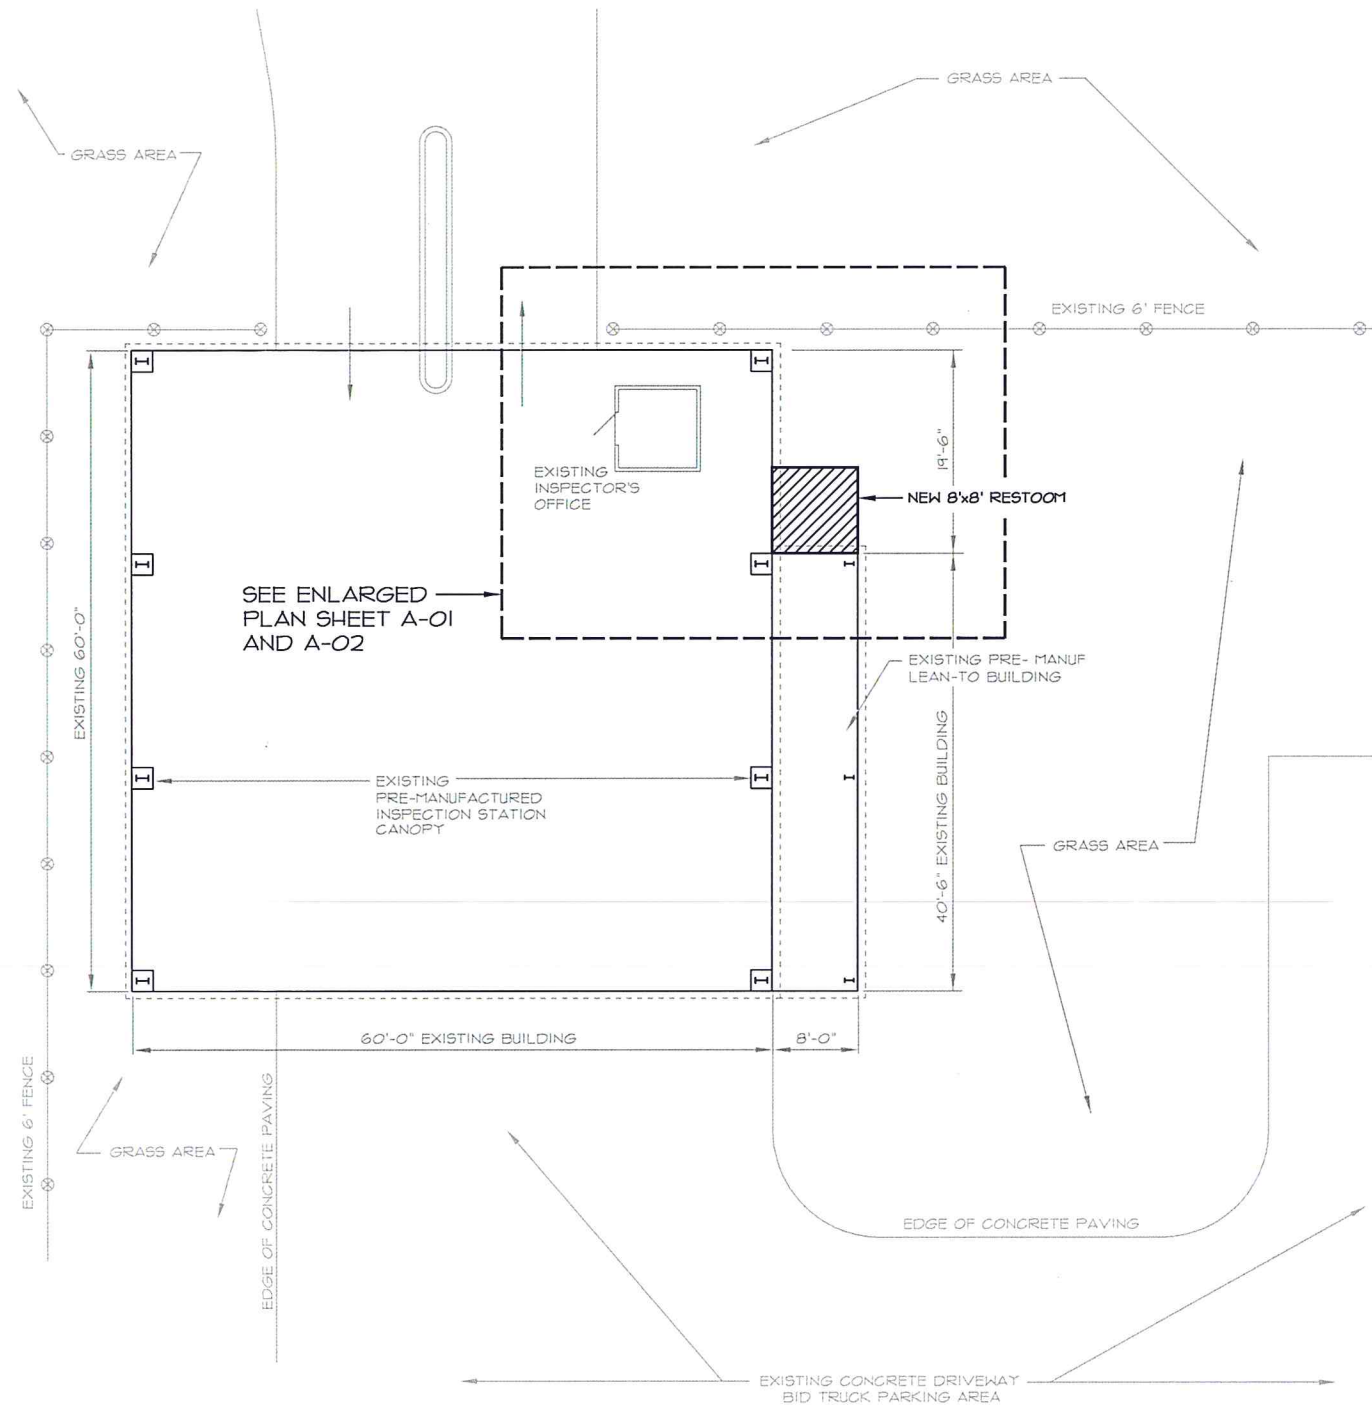


ENLARGED EXISTING SITE PLAN
SCALE: 1"=50'-0"



**EXECUTIVE
DIRECTOR
APPROVAL**


Date 7/7/17 By [Signature]

NO.	REVISIONS	BY	DATE

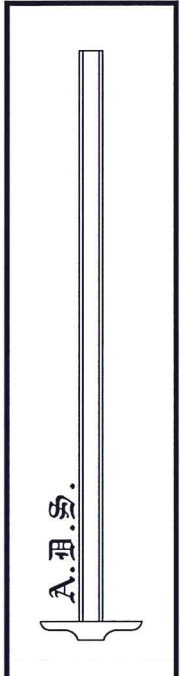


RESTROOM ADDITION
COCA COLA ENTERPRISES INC
SHREVEPORT SALES CENTER
5405 CAMPUS DRIVE
SHREVEPORT, LOUISIANA
76300
ENLARGED SITE PLAN

DATE	06/16/2017
SCALE	AS-SHOWN
LAST EDIT	
LAST PLOT	
DISK NO.	
SHEET NO.	
REVISION	
DRAWING NO.	A-01

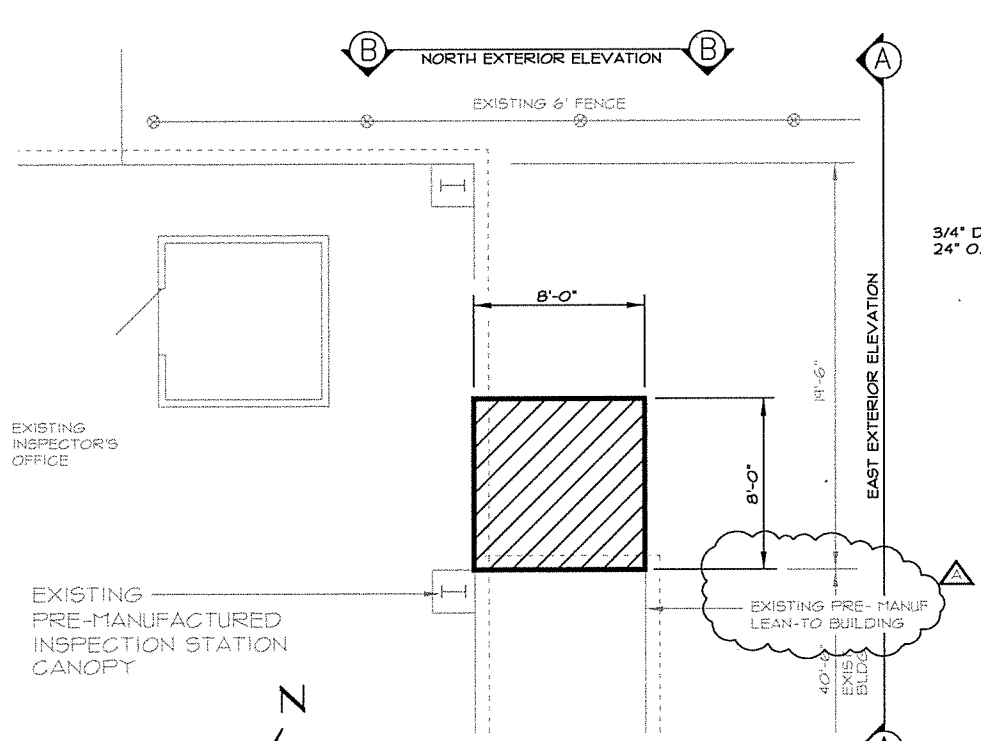


ENLARGED EXISTING FLOOR PLAN
SCALE: 1/4"=1'-0"


- NOTE:**
1. ACCESSIBLE TOILETS AND RAMPS SHALL BE INSTALLED IN ACCORDANCE WITH ANS1, A117.1-1980, AND THE AMERICANS WITH DISABILITIES ACT GUIDELINES.
 2. GRAB BARS TO BE T91-R4 36" OR 42" LONG WHERE REQUIRED.
- ALL CONSTRUCTION TO COMPLY WITH THE LATEST EDITIONS OF:
- 1) INTERNATIONAL BUILDING CODE (IBC) 2009
 - 2) NFPA 101 LIFE SAFETY CODE 2009
 - 3) NATIONAL ELECTRIC CODE (NEC) 2011
 - 4) IFBI & 2010 ADA STANDARDS
 - 5) LOUISIANA STATE PLUMBING CODE 2013
 - 6) INTERNATIONAL MECHANICAL CODE (IMC) 2009

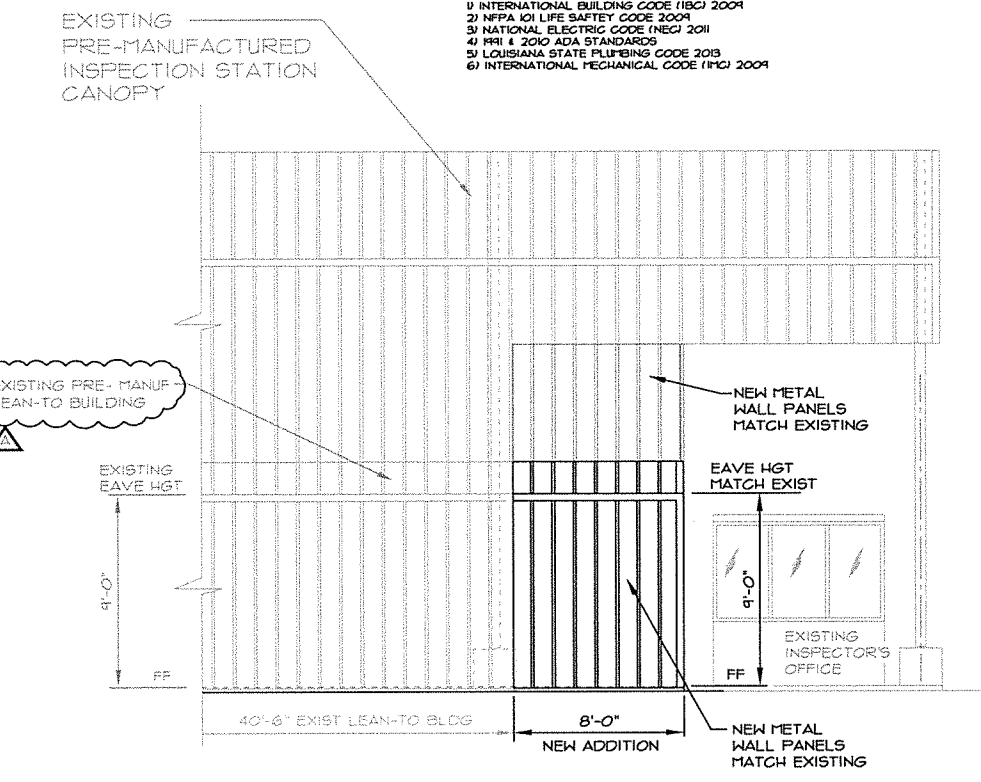


EAST ELEVATION "A-A"
SCALE: 1/4"=1'-0"

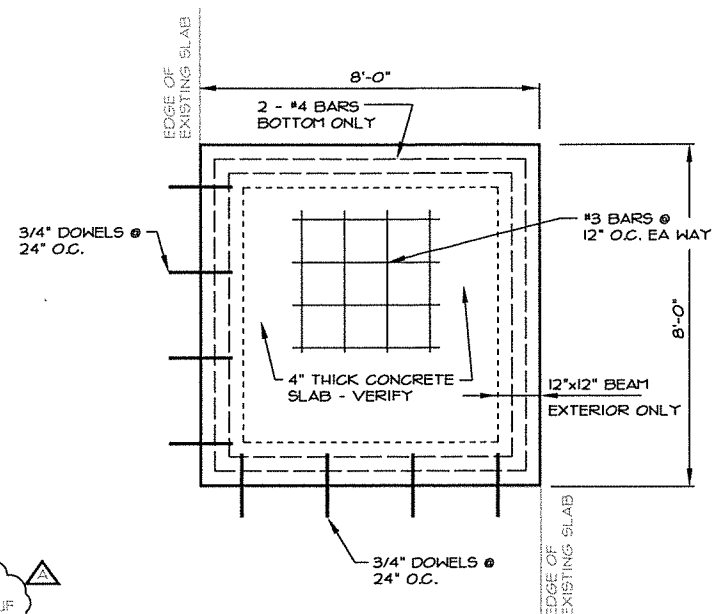


ADDITION FOUNDATION PLAN
SCALE: 1/2"=1'-0"

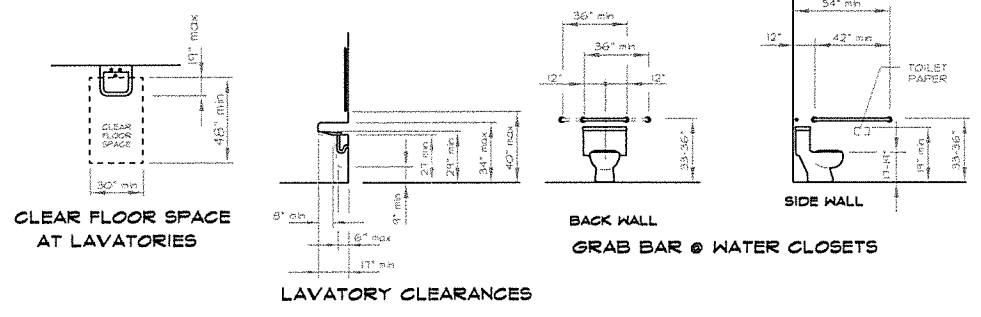


LAVATORY CLEARANCES

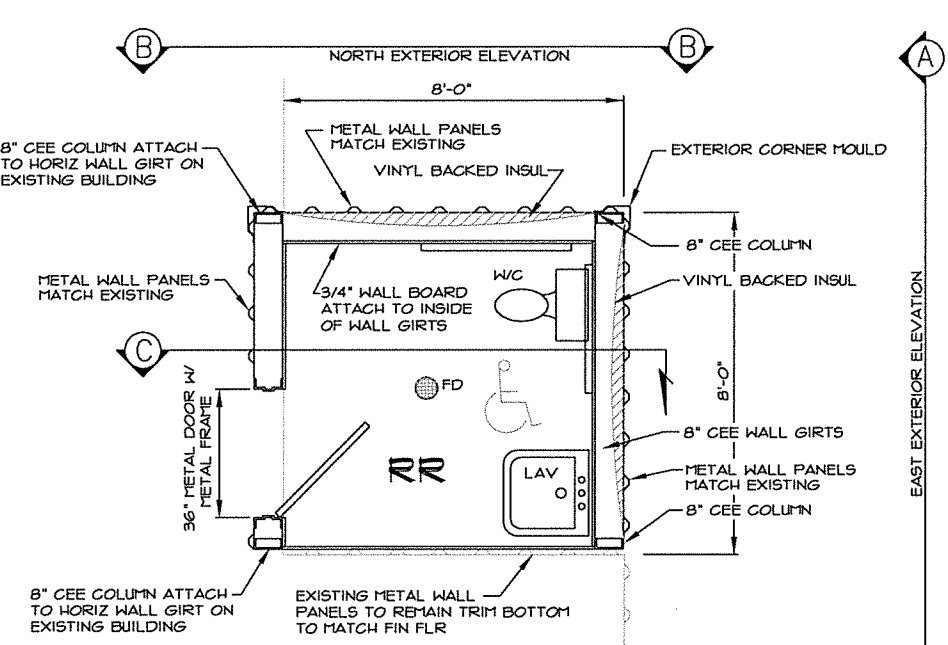

ADDITION FLOOR PLAN
SCALE: 1/2"=1'-0"

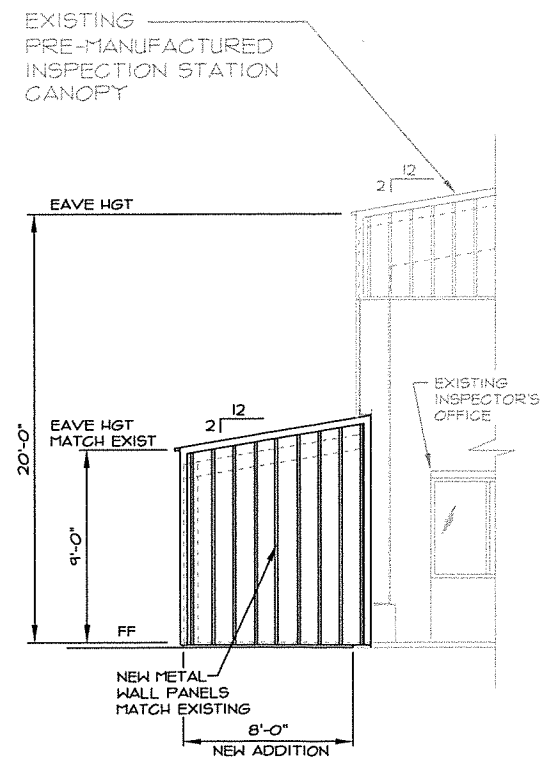


NORTH ELEVATION "B-B"
SCALE: 1/4"=1'-0"

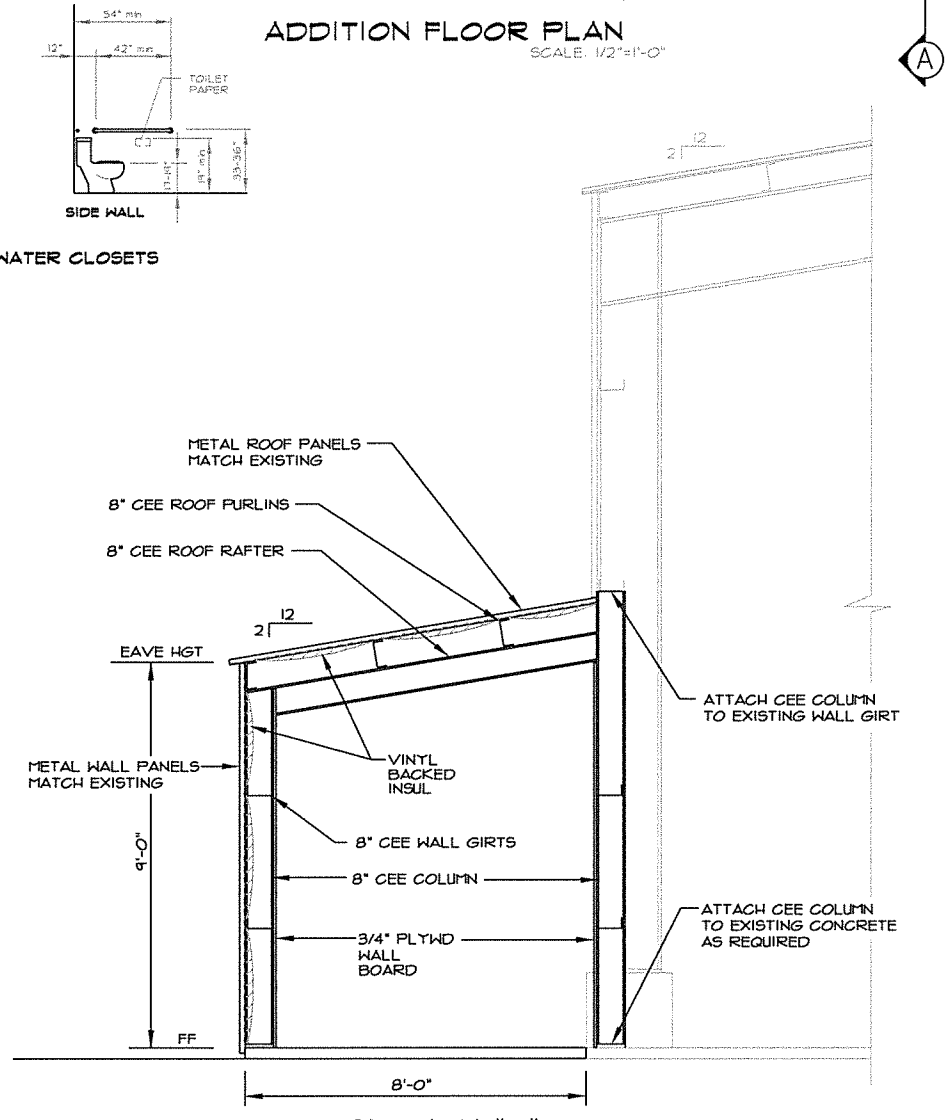


SECTION "C"
SCALE: 1/4"=1'-0"

NO.	REVISIONS	BY	DATE
1	CLARIFY EXISTING LEAN-TO BLDG	SAC	6/16/11

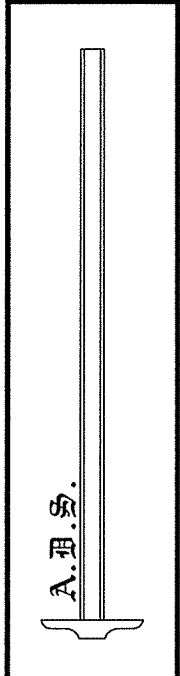


RESTROOM ADDITION
COCA COLA ENTERPRISES INC
SHREVEPORT SALES CENTER
5405 CAMPUS DRIVE
SHREVEPORT, LOUISIANA
FOUNDATION & FLOOR PLANS
ELEVATIONS & SECTIONS


DATE	06/16/2017
SCALE	AS-SHOWN
LAST EDIT	
LAST PLOT	
BY	
NO.	
SHEET NO.	REVISION
	A
DRAWING NO.	
A-02	

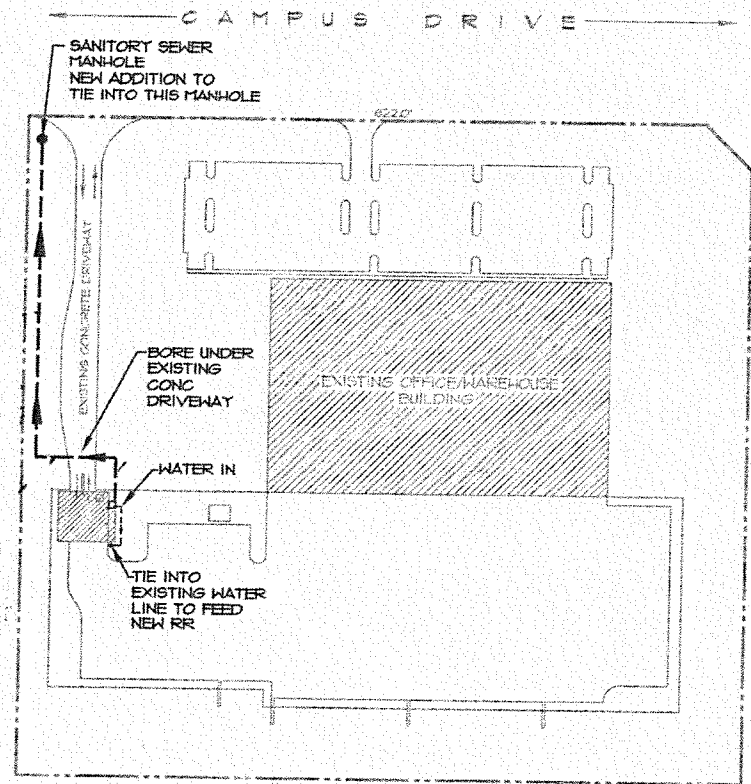

OVERALL PLUMBING SEWER SITE PLAN
SCALE: 1"=100'-0"

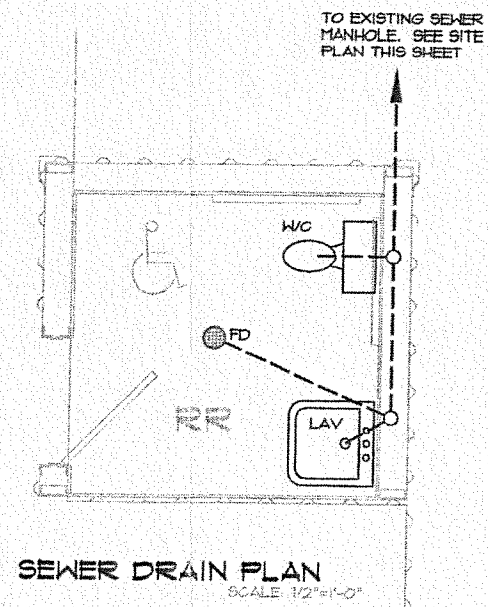


SEWER DRAIN PLAN
SCALE: 1/2"=1'-0"

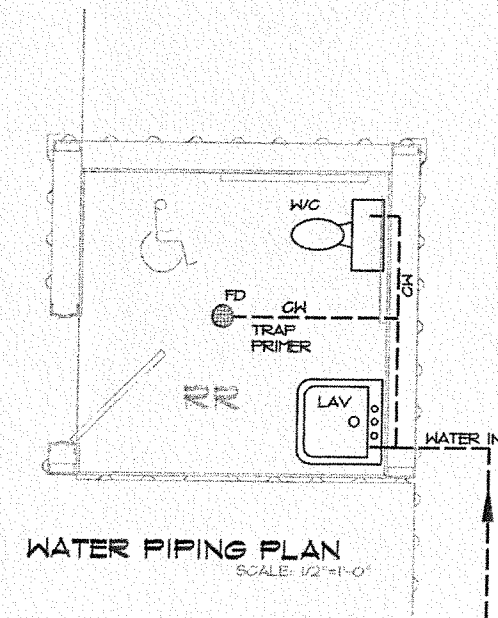

WATER PIPING PLAN
SCALE: 1/2"=1'-0"

ELECTRICAL SYMBOLS	
	120 VOLT OUTLET (SFCI)
LIGHTING LEGEND	
	2x4 FLUORESCENT LIGHT FIXTURE 4 LAMP
	SWITCH

ELECTRICAL NOTE:
RUN NEW CIRCUIT FROM EXISTING ELECTRIC PANEL IN EXISTING BUILDING

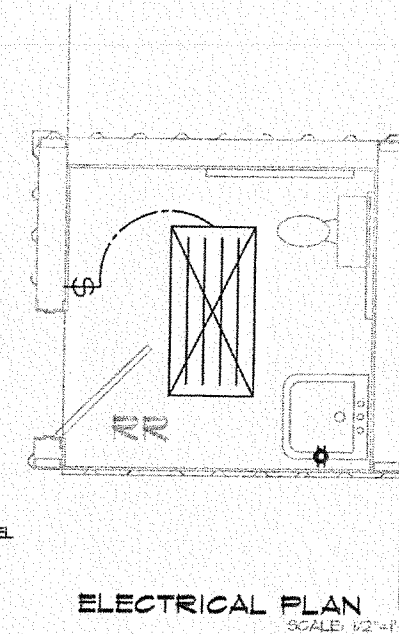

ELECTRICAL PLAN
SCALE: 1/2"=1'-0"

NO.	REVISIONS	DATE

A. J. S.

RESTROOM ADDITION
COCA COLA ENTERPRISES INC
SHREVEPORT SALES CENTER
3405 CAMPUS DRIVE
SHREVEPORT, LOUISIANA

SEWER & WATER PLUMBING PLANS, ELECTRICAL PLANS

DATE	12/26/2016
DRAWN BY	SAC/ADS
SCALE	AS-SHOWN
LAST EREV	
LAST PLOT	
CHK REL	
SHEET NO	REVISION
DRAWING NO	
A-03	