


SELF STORAGE – SOUTHERN LOOP  
 2147 SOUTHERN LOOP, SHREVEPORT, LA 71106  
ADDITION OF OUTDOOR BOAT/RV PAVILION – PHASE 2  
 (AT REAR OF PROPERTY)

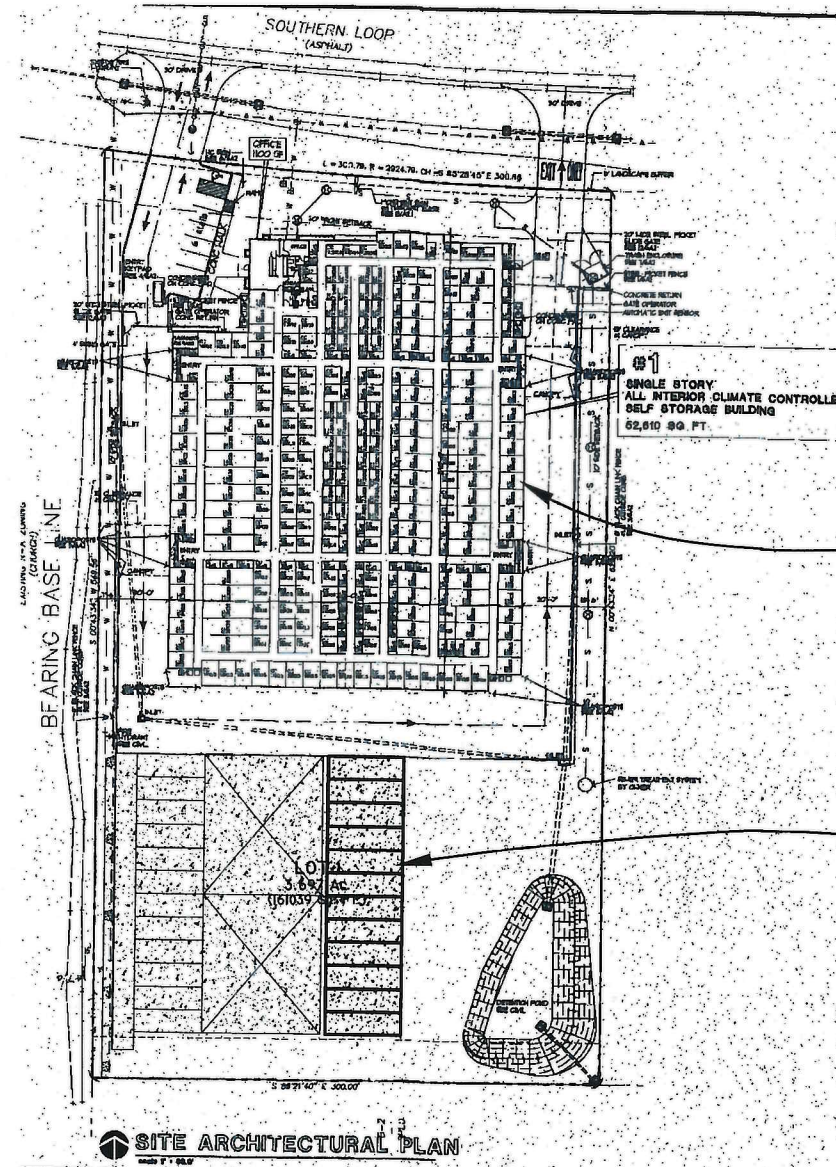


EXISTING SITE AND STORAGE FACILITIES

PROPOSED OUTDOOR STORAGE FACILITIES

EXECUTIVE  
 DIRECTOR  
 APPROVAL


4-30-2021  
 Date By *[Signature]*

**SITE PLAN**  
 SCALE: 1" = 50'

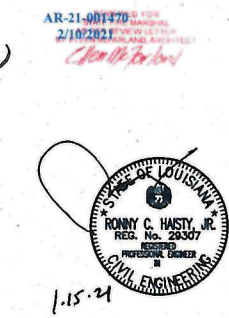

DESIGNED CHECKED	RCH, JR.	PARCH	CADD
DATE SHEET	RCH, SR.	PROJECT NUMBER	21E020
NO.	RCH, JR.	CITY & STATE	SHREVEPORT LOUISIANA
DATE	1-15-21		
REASON DESCRIPTION			
<b>SITE PLAN/COVER SHEET</b>			
<b>SELF STORAGE - SOUTHERN LOOP</b>			
2147 SOUTHERN LOOP, SHREVEPORT, LA 71106			
ENGINEERING & LAND SURVEYING P.O. BOX 2653 WEST MONROE, LOUISIANA 71294 1-318-387-5335			
<b>RCH</b> C.O.M.P.A.N.Y.			
SHEET NO.			
<b>C.1</b>			

21-19-P

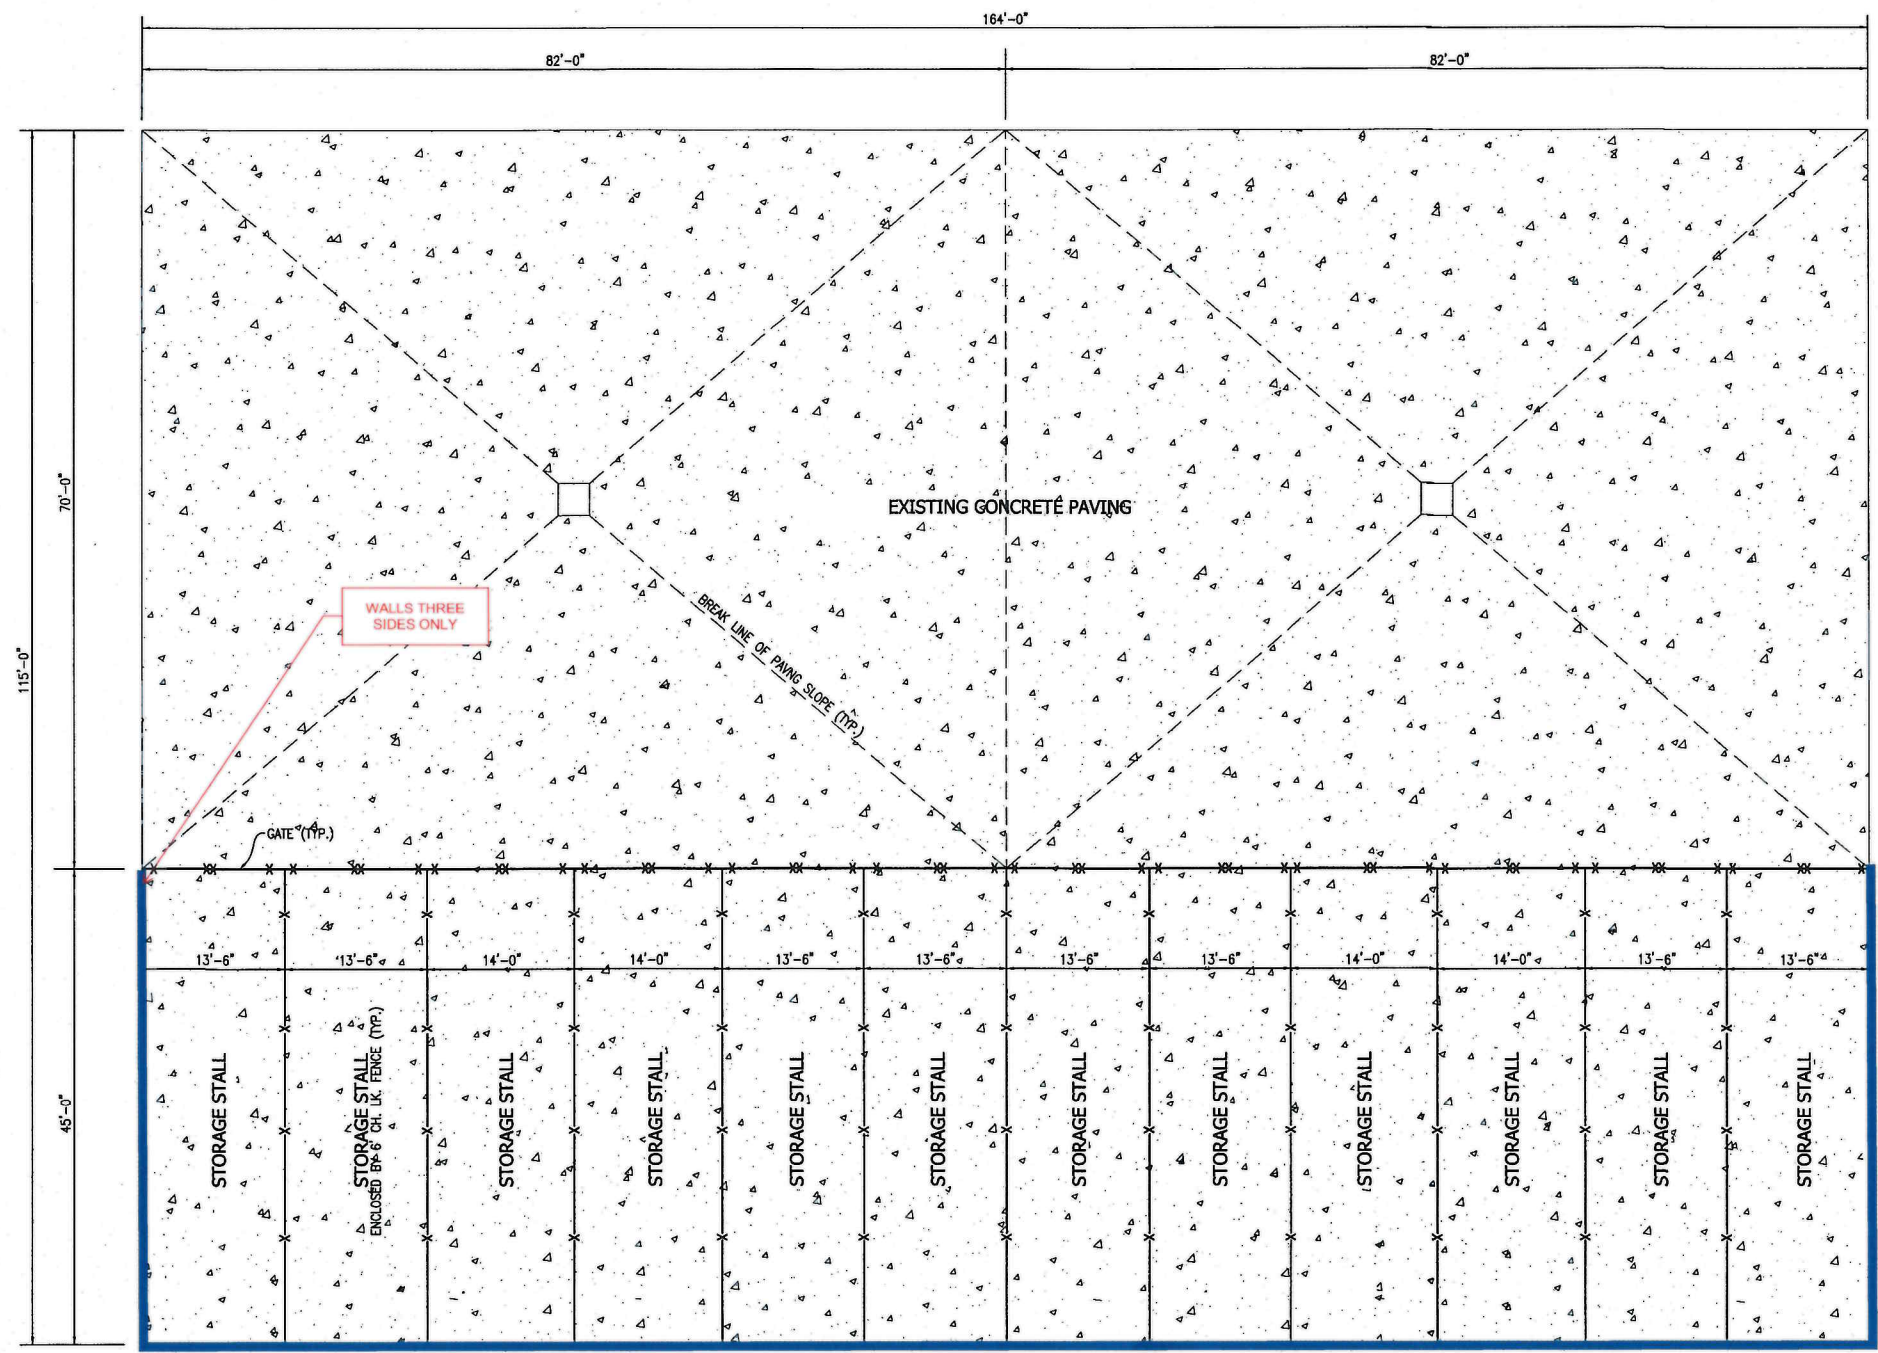

**FLOOR PLAN**  
SCALE: 1/8" = 1'-0"


EXECUTIVE  
DIRECTOR  
APPROVAL

4-30-2021  
Date By *all*


AR-21-001470  
2/10/2021  
*Chen H. Barlow*




DESIGNED	RCH, JR.	PARISH	CADDO
CHECKED		PROJECT NUMBER	21E020
DATE	5-15-19	CITY & STATE	SHREVEPORT LOUISIANA
REVISION DESCRIPTION			
NO.	DATE		BY
<b>FLOOR PLAN</b>			
<b>SELF STORAGE - SOUTHERN LOOP</b>			
Southern Loop, Shreveport, LA			
ENGINEERING & LAND SURVEYING C. O. BOY, 2653 WEST MONROE, LOUISIANA 71294 1-318-387-5335			
<b>RCH</b> C.O.M.P.A.N.Y.			
SHEET NO. <b>A.1</b>			

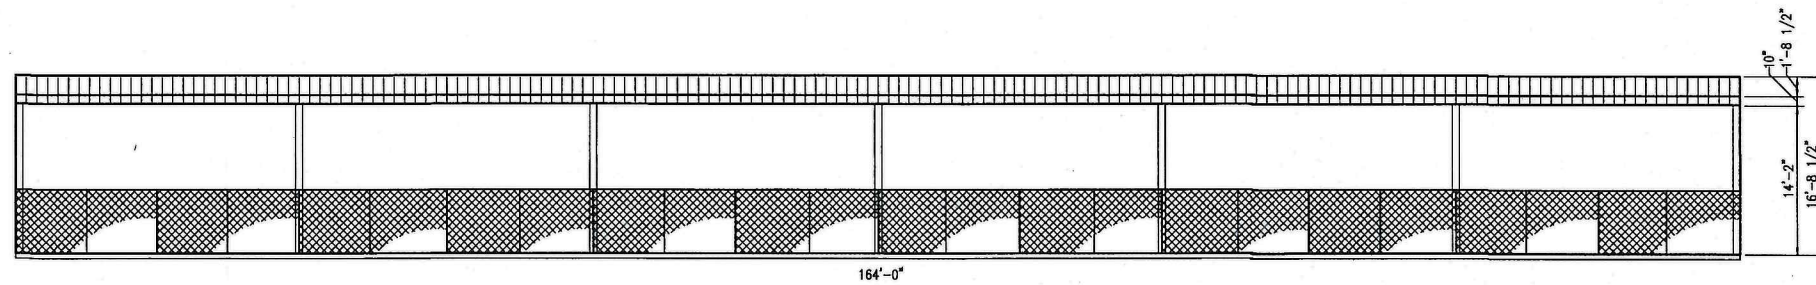


**FRONT ELEVATION**

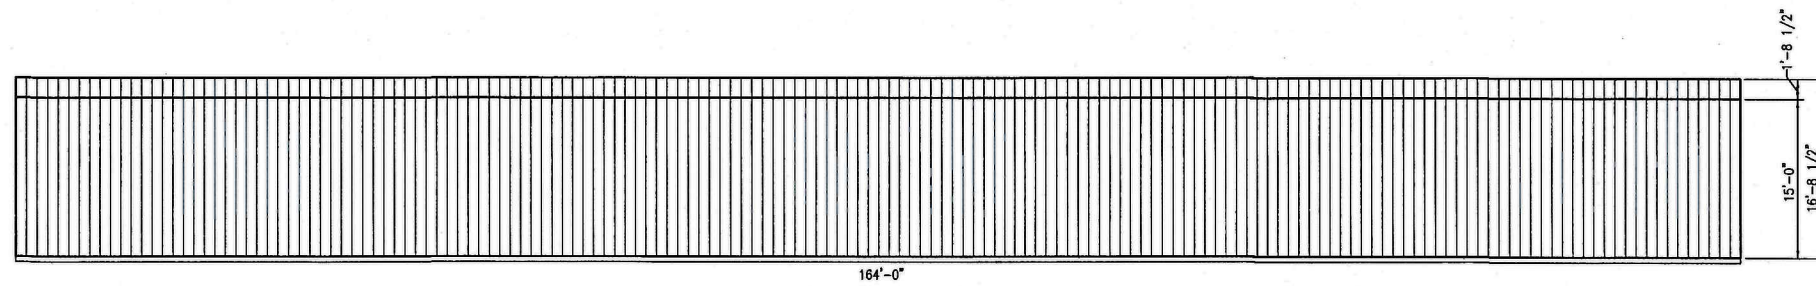

**REAR ELEVATION**

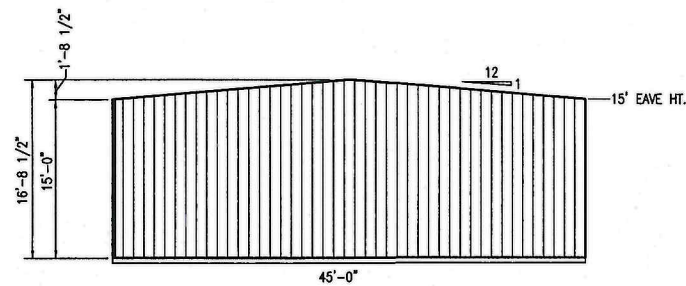

**LEFT ELEVATION**

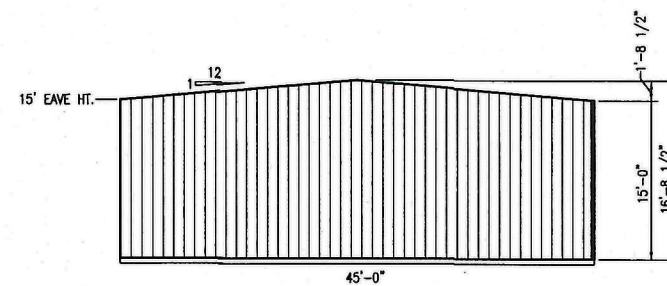

**RIGHT ELEVATION**

**ELEVATIONS**

SCALE: 1/8" = 1'-0"

**EXECUTIVE  
DIRECTOR  
APPROVAL**


**4-30-2021**  
Date

*[Signature]*  
By

AR-21-001470  
2/18/2021  
*[Signature]*



DESIGNED	RCH, JR.	CADD
CHECKED		PARISH
DATE	5-15-19	PROJECT NUMBER
SHEET		CITY & STATE
		SHREVEPORT LOUISIANA
ELEVATIONS		
SELF STORAGE - SOUTHERN LOOP		
Southern Loop, Shreveport, LA		
ENGINEERING & LAND SURVEYING		
P.O. BOX 2653		
WEST MONROE, LOUISIANA		
71294		
1-318-387-5335		
<b>RCH</b>		
C.O.M.P.A.N.Y.		
SHEET NO.		
<b>A.2</b>		

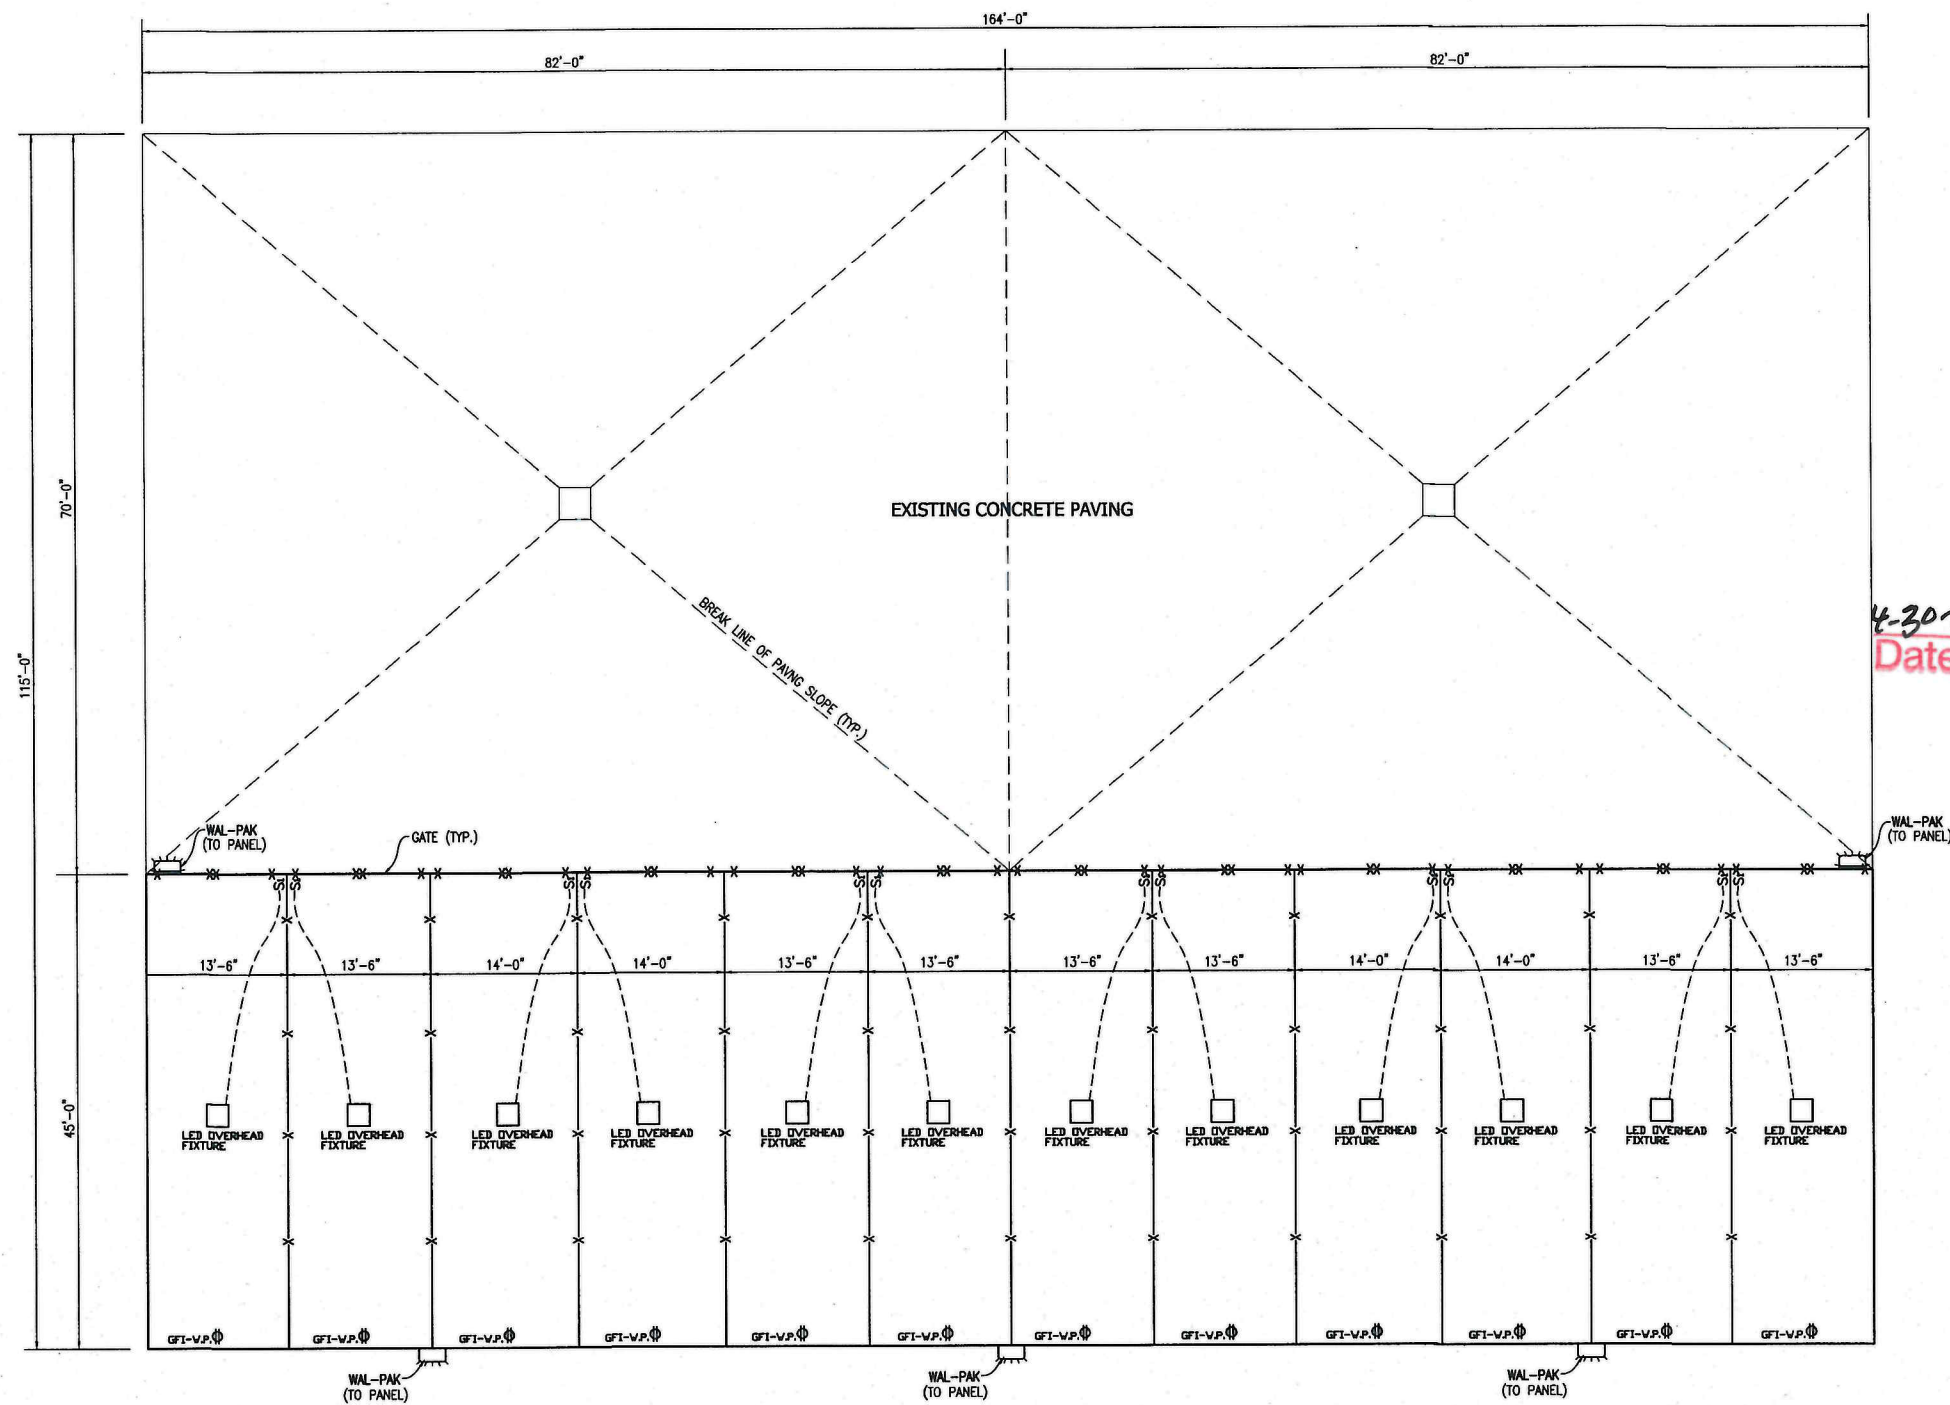


EXECUTIVE  
DIRECTOR  
APPROVAL

4-30-2021  
Date                      By                     

DESIGNED	RCH, JR.	PARISH	CADDO
CHECKED	RCH, SR.	PROJECT NUMBER	21E020
DATE	5-15-19	CITY & STATE	SHREVEPORT LOUISIANA
REVISION DESCRIPTION	NO.	DATE	BY
<b>ELECTRICAL PLAN</b> <b>SELF STORAGE - SOUTHERN LOOP</b> Southern Loop, Shreveport, LA			
ENGINEERING & LAND SURVEYING P.O. BOX 2653 WEST MONROE, LOUISIANA 71294 1-318-387-5335			
SHEET NO. <b>E.1</b>			

**ELECTRICAL PLAN**  
SCALE: 1/8" = 1'-0"

21-19-P

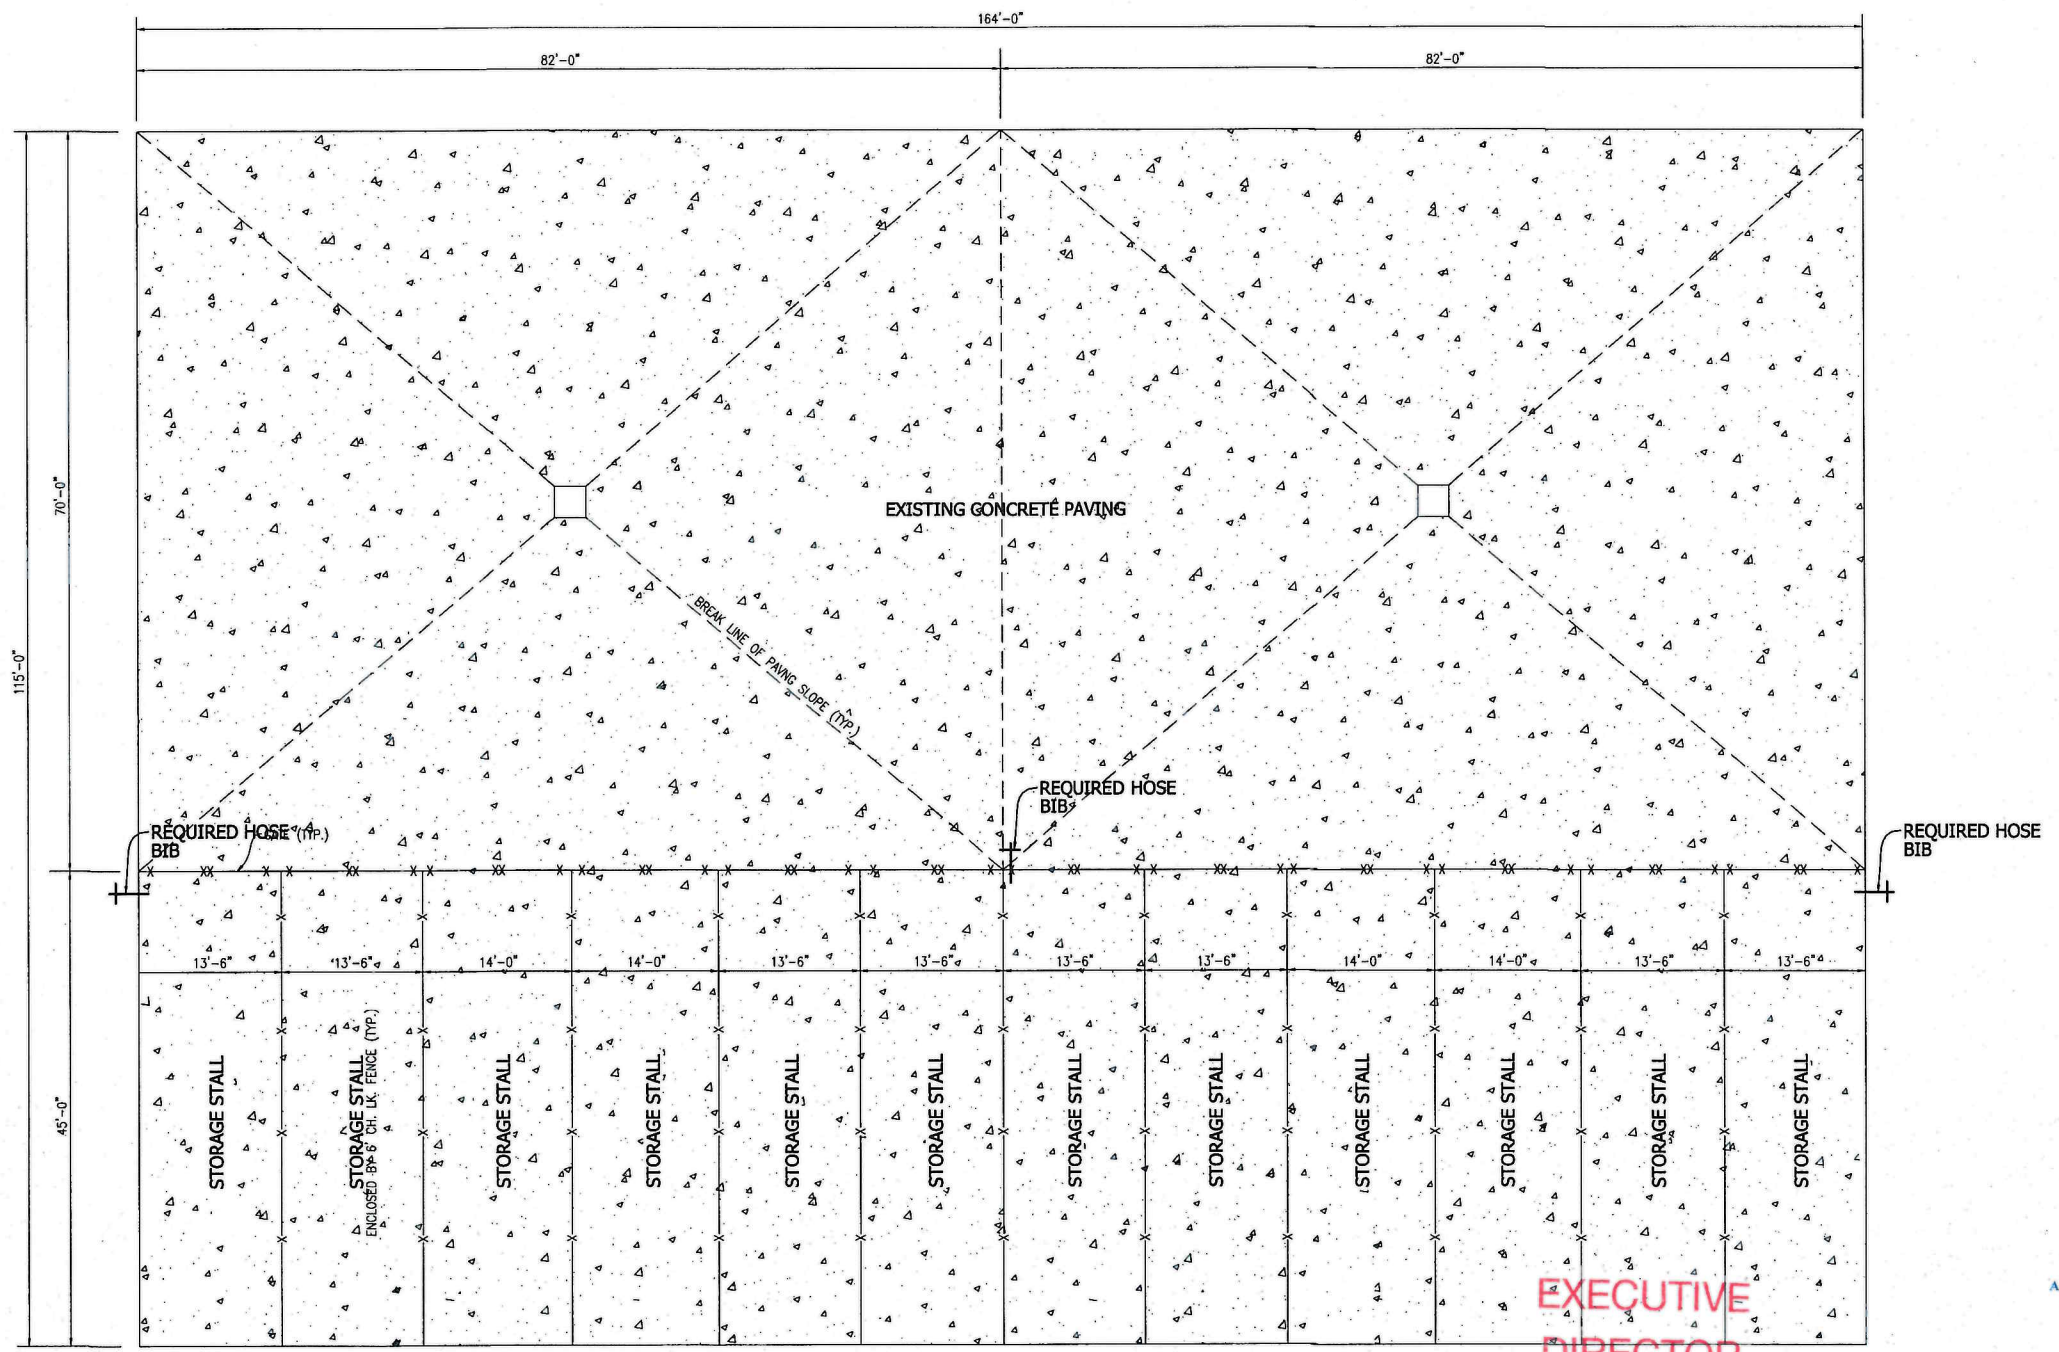


**PLUMBING PLAN**


SCALE: 1/8" = 1'-0"

**EXECUTIVE  
DIRECTOR  
APPROVAL**

4-30-2021 *Arch*  
Date By

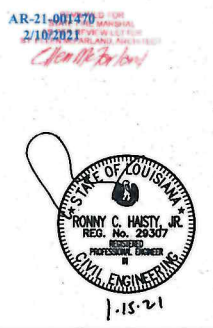

<b>PLUMBING PLAN</b> <b>SELF STORAGE - SOUTHERN LOOP</b> <small>Southern Loop, Shreveport, LA</small>		PARISH CADDO
(DESIGNED) CHECKED RCH, JR.	(DETAILED) CHECKED RCH, SR. RCH, JR.	PROJECT NUMBER 21E020
NO. DATE REVISION DESCRIPTION BY	DATE 5-15-19	CITY & STATE SHREVEPORT LOUISIANA
ENGINEERING & LAND SURVEYING P.O. BOX 2653 WEST MONROE, LOUISIANA 71294 1-318-387-5335		<b>RCH -&amp; A COMPANY</b>
SHEET NO. <b>P.1</b>		

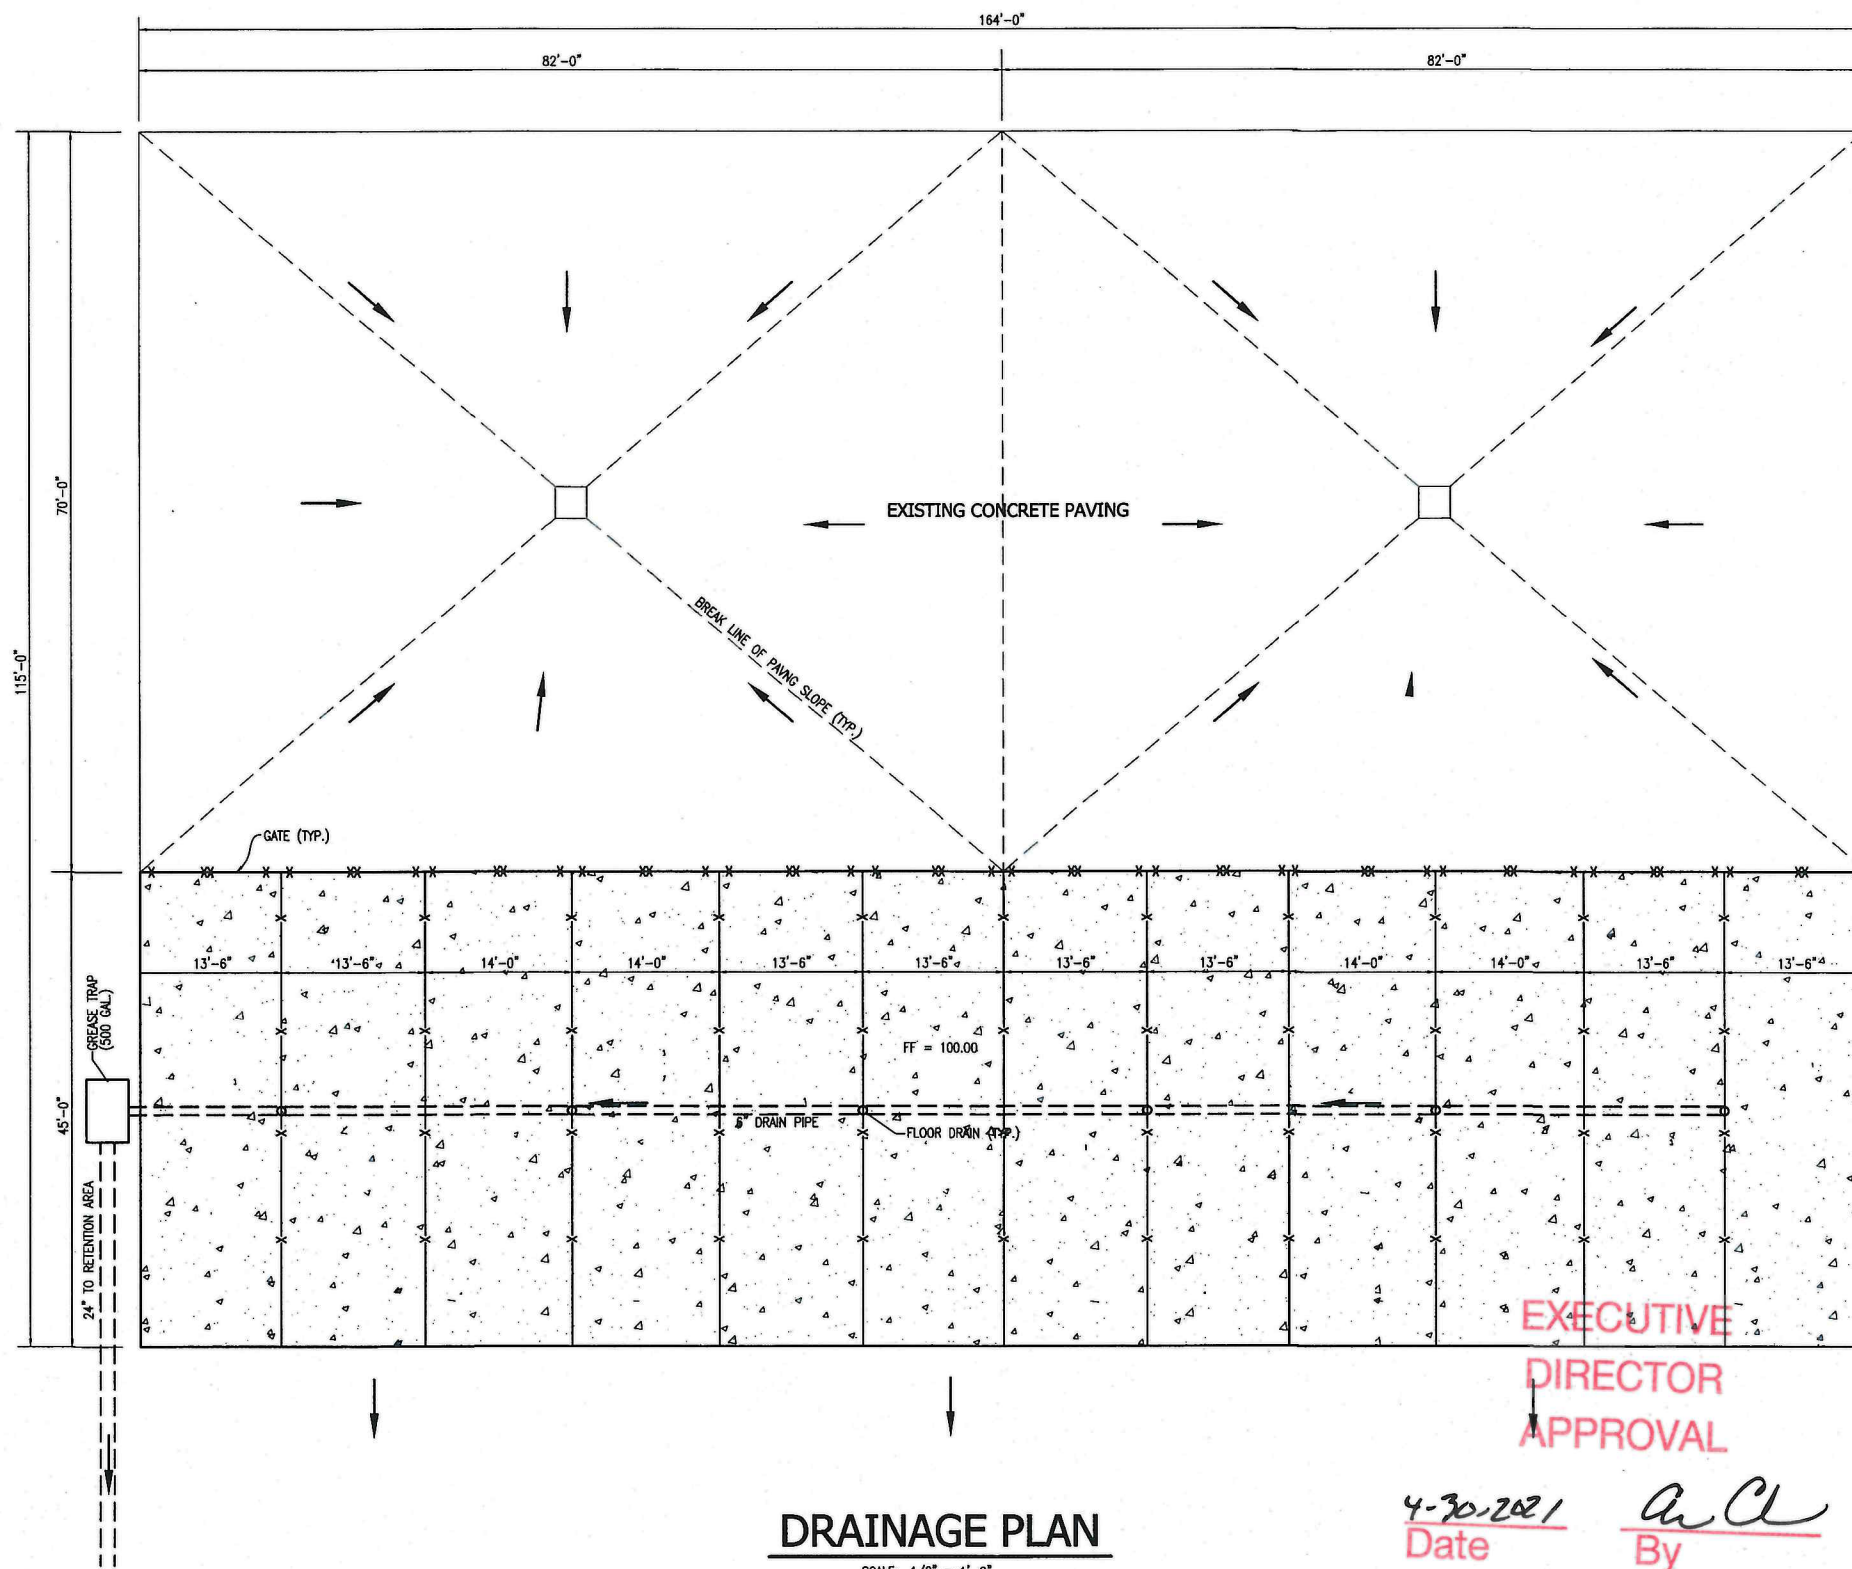


**DRAINAGE PLAN**

SCALE: 1/8" = 1'-0"

**EXECUTIVE  
DIRECTOR  
APPROVAL**

4-30-2021 *AC*  
Date By

AR-21-001470  
2/10/2021  
*Chad B. Forster*

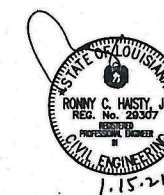

DESIGNED	RCH, JR.	PARISH	CADDO
CHECKED		PROJECT NUMBER	21E020
DETAILED	RCH, SR.	CITY & STATE	SHREVEPORT LOUISIANA
CHECKED	RCH, JR.	DATE	5-15-19
		SHEET	

**DRAINAGE AND GRADING PLAN**  
**SELF STORAGE - SOUTHERN LOOP**  
Southern Loop, Shreveport, LA


ENGINEERING  
& LAND SURVEYING  
P.O. BOX 2653  
WEST MONROE, LOUISIANA  
71294  
1-318-387-5335



SHEET NO.  
**DP**



2147 SOUTHERN LOOP, SHREVEPORT, LA 71106  
**ADDITION OF OUTDOOR BOAT/RV PAVILION – PHASE 2**  
 (AT REAR OF PROPERTY)

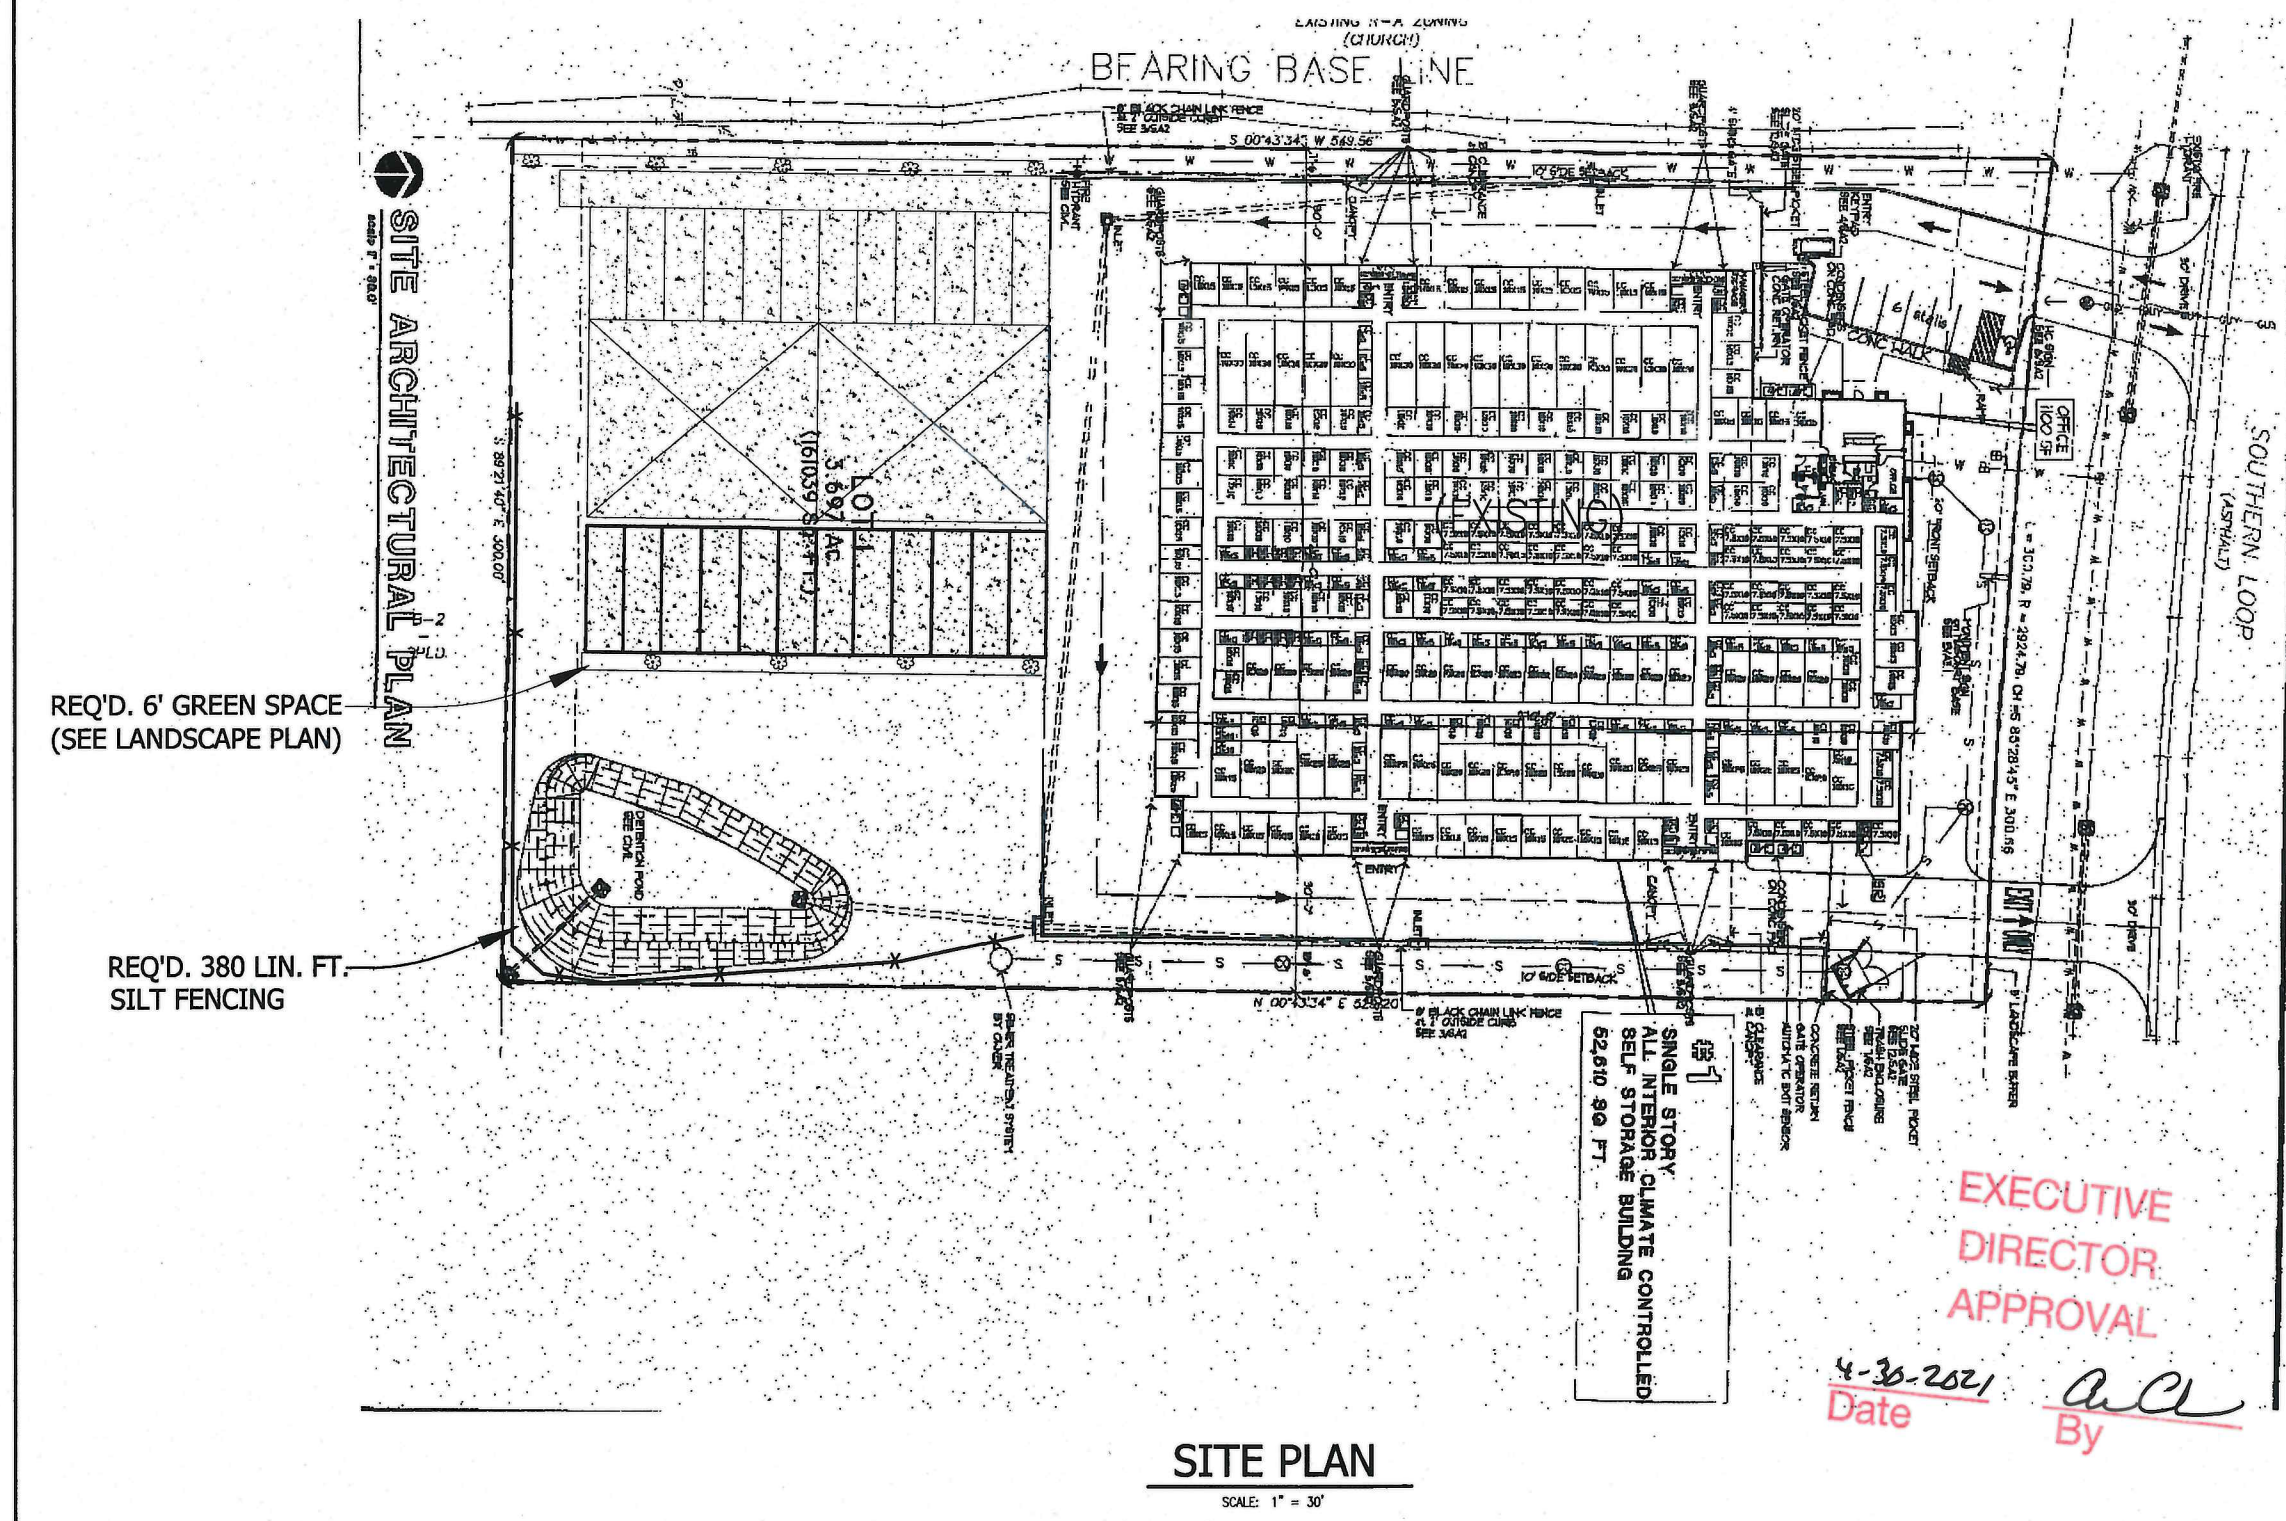

**SITE ARCHITECTURAL PLAN**  
 Scale: 1" = 30'

REQ'D. 6' GREEN SPACE  
 (SEE LANDSCAPE PLAN)


REQ'D. 380 LIN. FT.  
 SILT FENCING

**SITE PLAN**  
 SCALE: 1" = 30'

SINGLE STORY,  
 ALL INTERIOR CLIMATE CONTROLLED  
 SELF STORAGE BUILDING  
 52,610 SQ. FT.

**EXECUTIVE DIRECTOR APPROVAL**  
 Date: 4-30-2021 By: *ACL*

AR-21-001370  
 2/16/2021  
*Chantel B. Lewis*

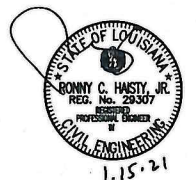

DESIGNED	CH. JR.	PARISH	CADDO
CHECKED		PROJECT NUMBER	21E020
DATE	1-15-21	CITY & STATE	SHREVEPORT LOUISIANA
REVISION DESCRIPTION	NO.	DATE	BY
<b>EROSION CONTROL PLAN</b> <b>SELF STORAGE - SOUTHERN LOOP</b> 2147 SOUTHERN LOOP, SHREVEPORT, LA 71106			
ENGINEERING & LAND SURVEYING P.O. BOX 2653 WEST MONROE, LOUISIANA 71294 1-318-587-5335			
SHEET NO. <b>EC.1</b>			

21-19-P